


PO Box 25774
GREENVILLE, SC 29616-0774
864-235-2724
FAX 864-990-3070
rick@bynumarchitecture.com
www.bynumarchitecture.com

© COPYRIGHT 2018 ALL RIGHTS RESERVED
THIS DRAWING IS AN INSTRUMENT OF SERVICE, IS THE PROPERTY OF BYNUM ARCHITECTURE, IT IS TO BE USED ON THE PROJECT AND THE SITE SPECIFIC HEREIN. IT IS NOT TO BE REPRODUCED, COPIED, REPRODUCED, OR TRANSMITTED IN ANY FORM OR BY ANY MEANS, ELECTRONIC OR MECHANICAL, WITHOUT THE WRITTEN PERMISSION OF BYNUM ARCHITECTURE. IF IT IS TO BE RETURNED UPON REQUEST.

SEALS:

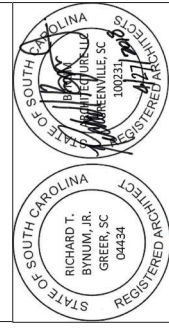

PROJECT:
OAK HILL CAFE
2510 POINSETT HIGHWAY
GREENVILLE, SC
GREENVILLE COUNTY

PROJECT NUMBER:
21721

ISSUE DATE:
APRIL 27, 2018

ISSUE TYPE:
PERMIT & CONSTRUCTION

NOTES:


SHEET TITLE:
**EQUIPMENT
PLAN-REFERENCE
ONLY**

SHEET NO.:
A103

EQUIPMENT SCHEDULE

Item No	Qty	Equipment Category	Manufacturer	Model Number	Equipment Remarks
1	1	Refrigerator, Sandwich/Salad Prep	Turbo Air	MST-28	-
2	1	Table, Work	John Boos & Co.	STBR5-3060SSK	w/Sink
3	1	Table, Work, Enclosed Base	John Boos & Co.	EB056-3084	w/intermediate Shelf
4	4	Heat Lamp, Decorative	Hatco	DL-775	Ceiling Mounted on Retractable Cord
5	1	Spare	-	-	-
6	1	Refrigerator, Sandwich/Salad Prep	Turbo Air	MST-36	-
7	1	Table, Baker's w/Splash	John Boos & Co.	SBO-508	w/ 22" X 34" Cutout For Granite Insert
8	2	Oven-Steamer, Combination, Electric	Unox, Inc.	XVC-06FS-EPR	-
9	1	EXHAUST HOOD	TBD	CUSTOM	-
10	3	Hand Sink	Serv-Ware	HS15S-CWP	-
11	1	Table, Work	John Boos & Co.	STB-2430SSK	-
12	1	Spare	-	-	-
13	1	Custom Cooking Island Suite	Jade	Custom	-
14	1	Spare	-	-	-
15	1	Spare	-	-	-
16	1	Table, Work	John Boos & Co.	STBR5-3084SSK	-
17	1	Walk-In Cooler	TBD	Custom	-
18	1	LOT Shelving, Wire	Winco	VEK-2442	72" Post, 4-Tiers Per Unit
19	1	Sink, Scullery, 3 Compartments	John Boos & Co.	3B16204-2D18	Add (1) 12-814, (3) 22-204
20	1	Shelving, Wire	Winco	VEK-2448	72" Post, 4-Tiers Per Unit
21	1	Dishhobble, Straight	John Boos & Co.	JDS-20-30UICL	Add (1) 17-108WL
22	1	Wreasher, Undercounter, High Temp	CMA Dismachines	CMA-180UC	-
23	1	Sink, Mop	John Boos & Co.	EMS-2016-12	Add (1) 16-127
24	1	Ice Maker, Undercounter	Manitowoc Ice	UR-0310A	-
25	1	Spare	-	-	-
26	1	Cooler, Bottle	Entree	BB-2SD-28	-

NOT SHOWN - STEAMER AT SOUTH END OF CHEF TABLE - OWNER TO PROVIDE INFO

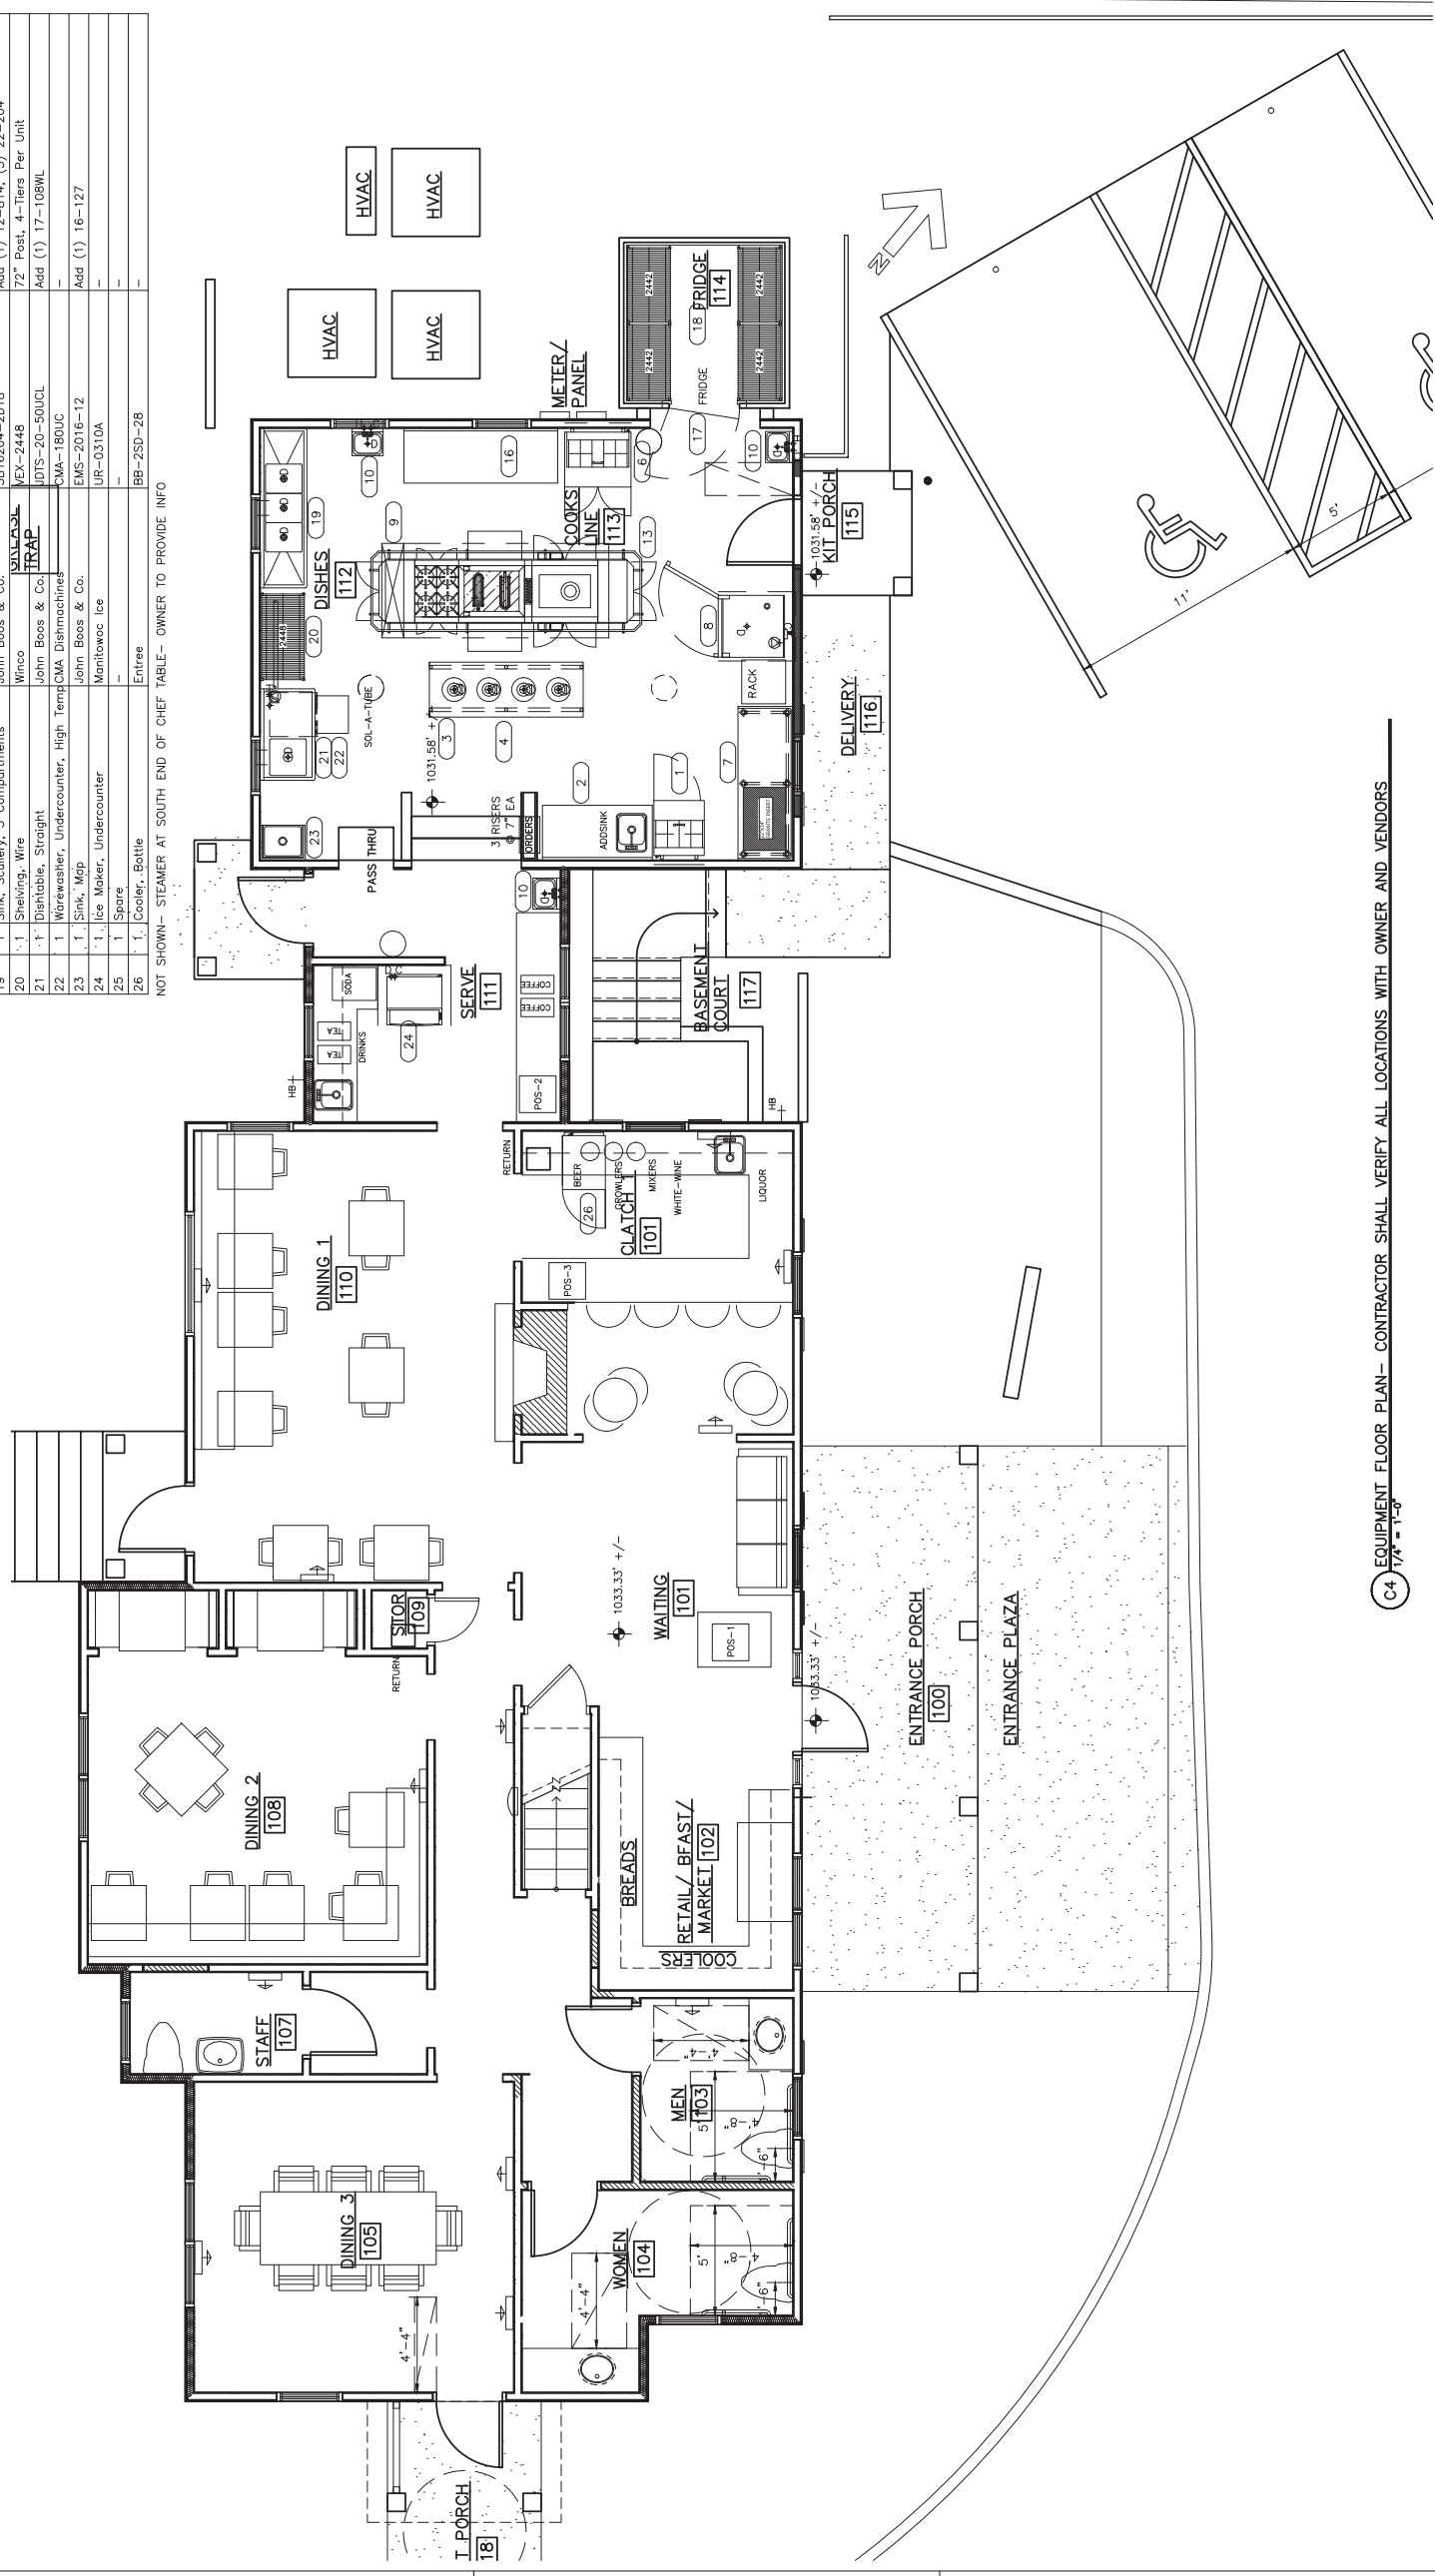

C4 EQUIPMENT FLOOR PLAN - CONTRACTOR SHALL VERIFY ALL LOCATIONS WITH OWNER AND VENDORS
1/4" = 1'-0"